
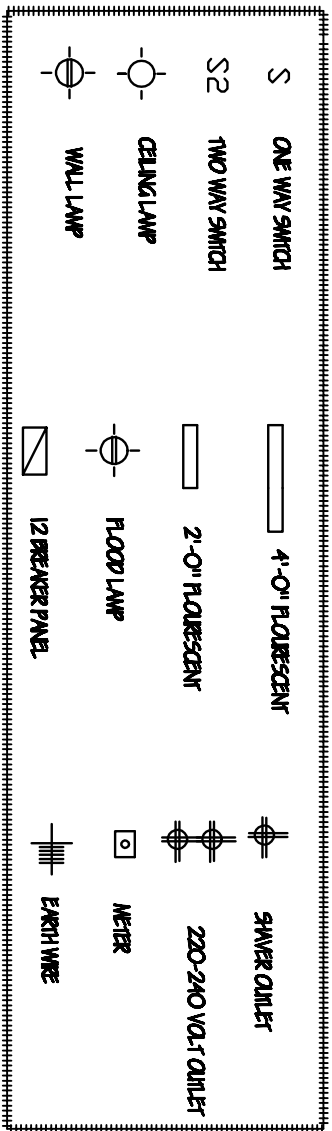


FLOOR PLAN (ELECTRICAL LAYOUT)
NOT SCALED

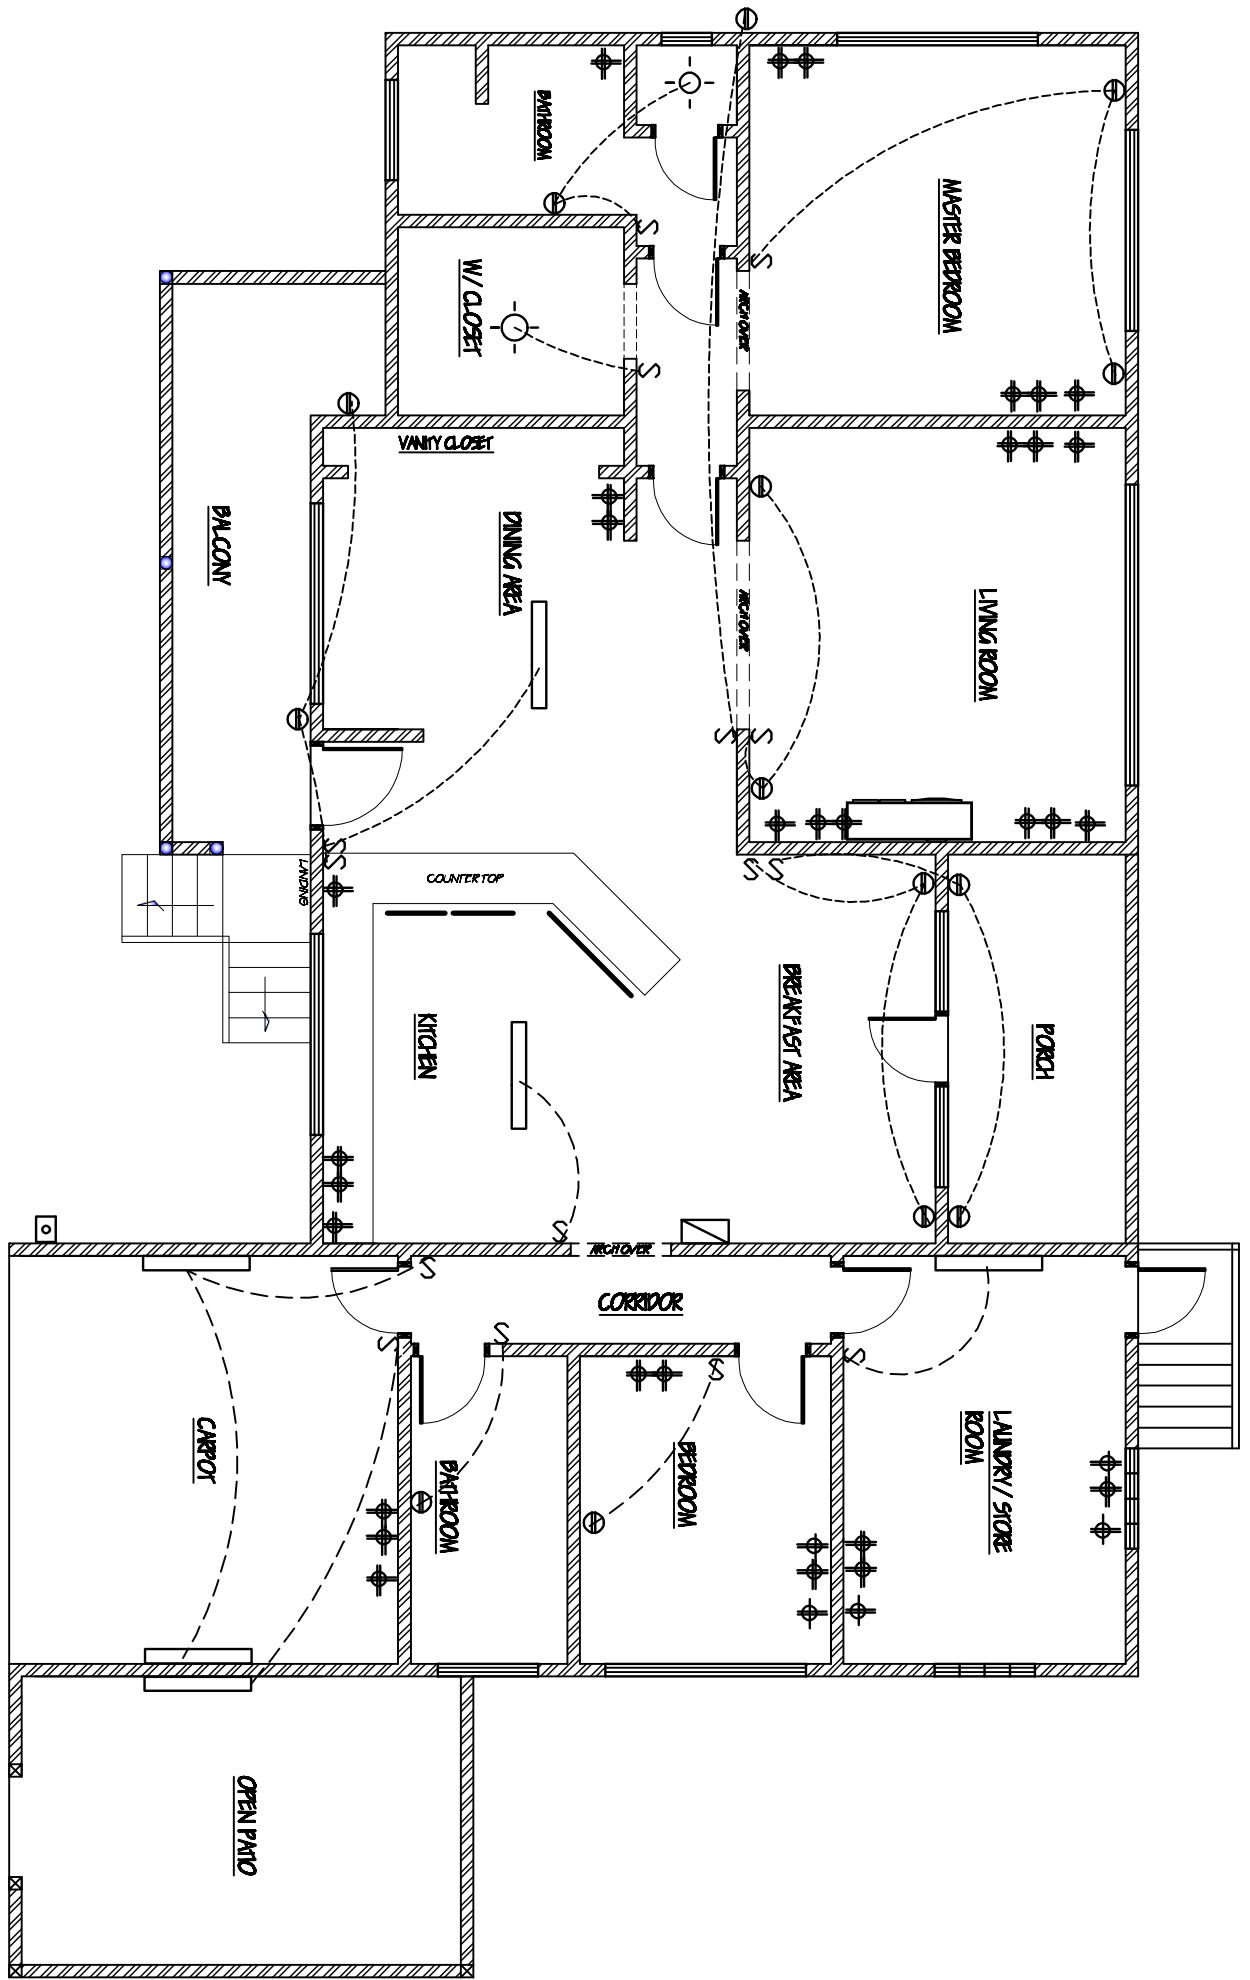

DESIGN BY: Ahmed's Designs and Allied Services

DRAWN BY: Ahmed's Designs and Allied Services

NOTE:
ANY CHANGES TO BE MADE SHOULD BE
DISCUSSED WITH DESIGNER/DRAFTSMAN

CLIENT:

Mr. and Mrs. JOSEPH BERTIN

LOCATION: BANGALOW ESTATE, LABORIE

DEVELOPMENT: RESIDENTIAL DWELLING

SCALE:

NOT SCALE

DATE:

JULY.2016

TITLE:

ELEC. LAYOUT



ADAS[®]

AHMED'S DESIGNS & ALLIED
SERVICES LTD.

DRAFTING, DESIGN, VALUATION AND
ESTIMATING SERVICES

TEL. # 723-8348

c/o : choleul po

SHEET NO.:

3A
06